

Monolithic Granite Slab Steps to be Cantilevered for a "Floating Stair" Effect. See Plans for Locations and Layout.

1 Stairs
Type 2
L-3.1

Not to Scale



Decorative Screen Fencing or Approved Equal. See Plans for Locations and Layout.

2 Fencing
L-3.1

Not to Scale



Decorative Railing Wood, Metal or Composite Railing w/ Stainless Steel Cable Wire or Approved Equal. See Plans for Locations and Layout.

3 Decorative Railing
L-3.1

Not to Scale



Green Screen Trellis as Manufactured and Supplied by Green Screen, 725 South Figueroa Street, Los Angeles CA 90017, or Approved Equal. See Plans for Locations and Layout.

4 Green Screen
L-3.1

5 Not Used
L-3.1


Not to Scale



Raised Metal Planter or Approved Equal. See Plans for Locations and Layout.

6 Planter
Type 1
L-3.1

Not to Scale

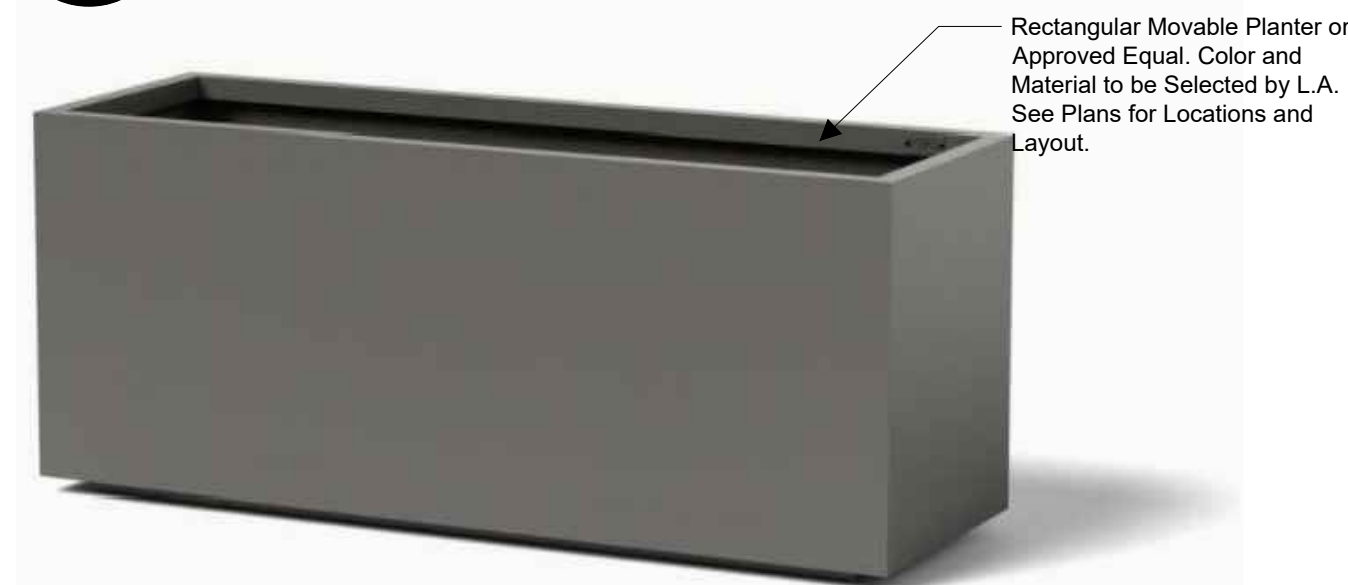

Rectangular Movable Planter or Approved Equal. Color and Material to be Selected by L.A. See Plans for Locations and Layout.

7 Planter
Type 2
L-3.1

Not to Scale



Round Movable Planter or Approved Equal. Color and Material to be Selected by L.A. See Plans for Locations and Layout.

8 Planter
Type 3
L-3.1

Not to Scale




Nautical Flag Pole- By Owner

9 Nautical Flagpole
L-3.1

Not to Scale



Wood Bollard @ 36" Height. Fixtures on Two Sides.

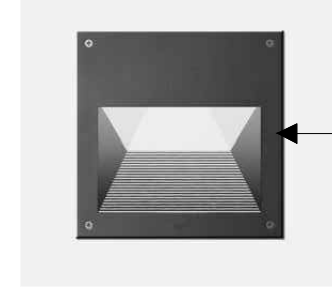

Recessed Light Fixture for Wood Bollard. See Proposed Lighting Schedule for Additional Information

10 Bollard Light
L-3.1

Not to Scale



Accent Light - See Proposed Lighting Schedule for Additional Information

11 Accent Light
L-3.1

Not to Scale



Step Light - See Proposed Lighting Schedule for Additional Information

12 Step Light
L-3.1


Not to Scale



Decorative Post Light Fixture w/ Matching Pole. See Proposed Lighting Schedule for Additional Information

13 Post Light
L-3.1


Not to Scale

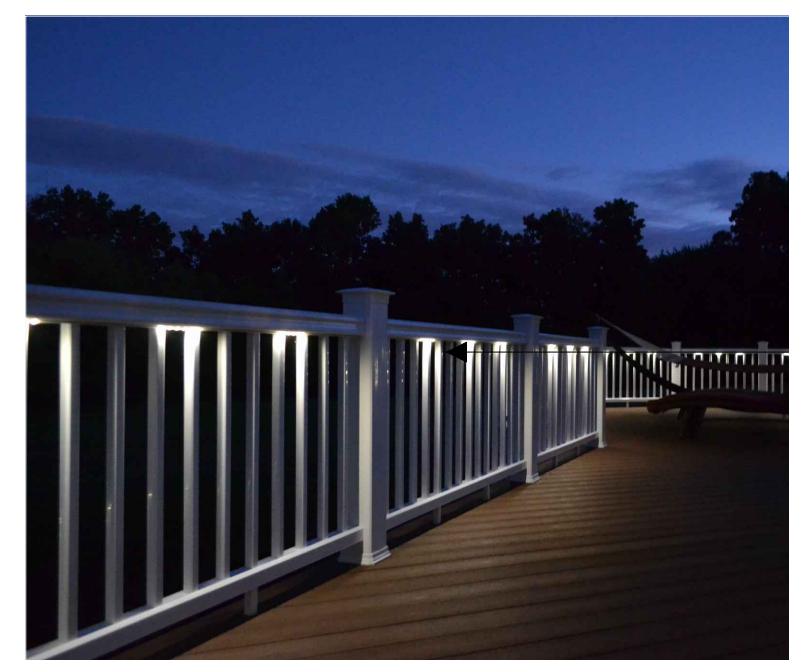

Rail Light - See Proposed Lighting Schedule for Additional Information


14 Rail Light
L-3.1

Not to Scale

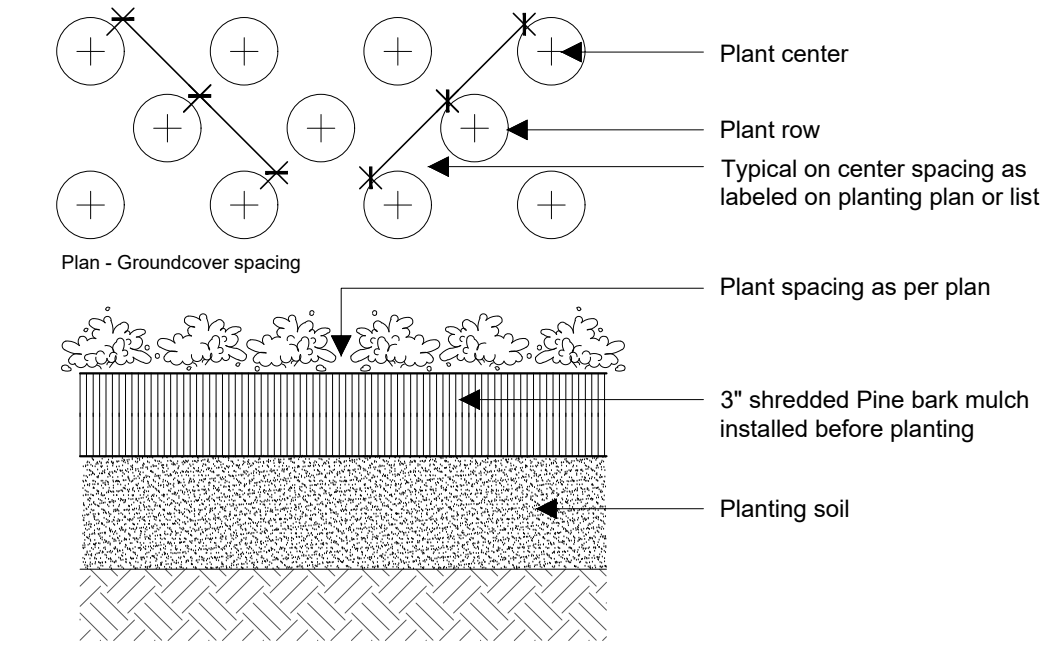


15 Groundcover Planting
L-3.1

Not to Scale

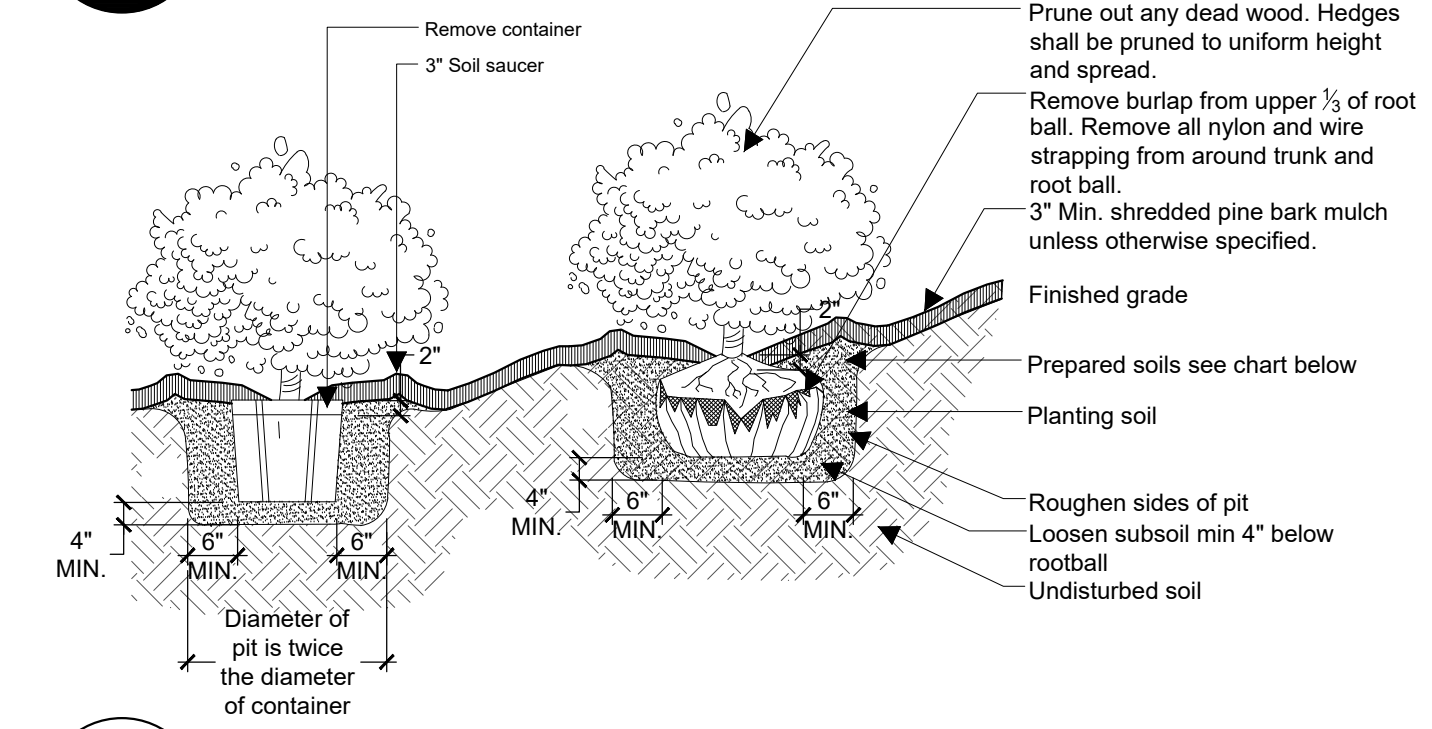


16 Planting Pit for Shrubs
L-3.1

Not to Scale

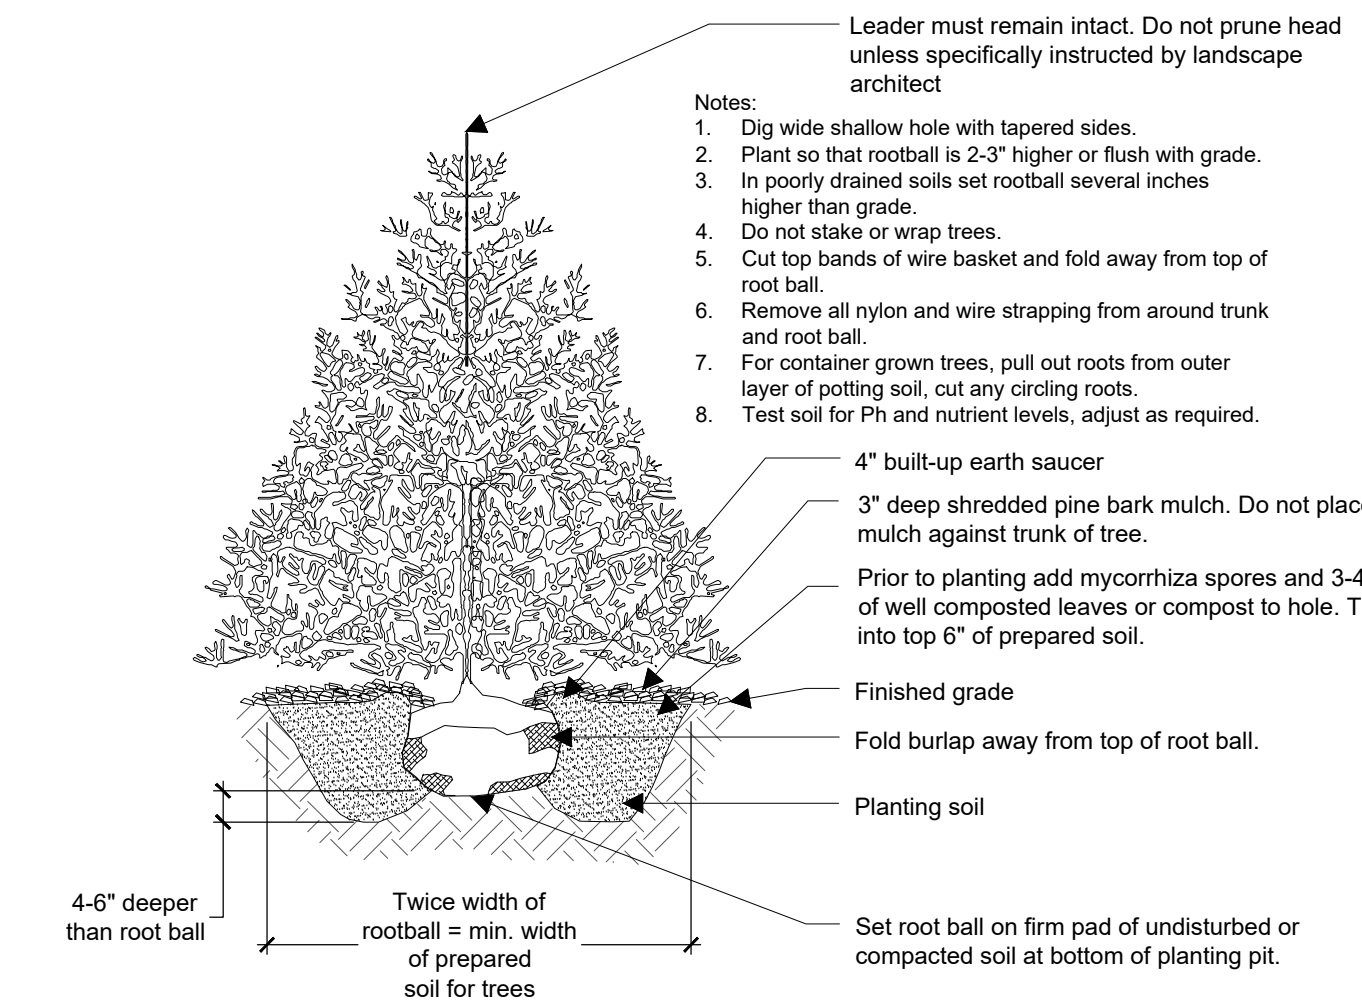

17 Evergreen Tree Planting
L-3.1

Not to Scale

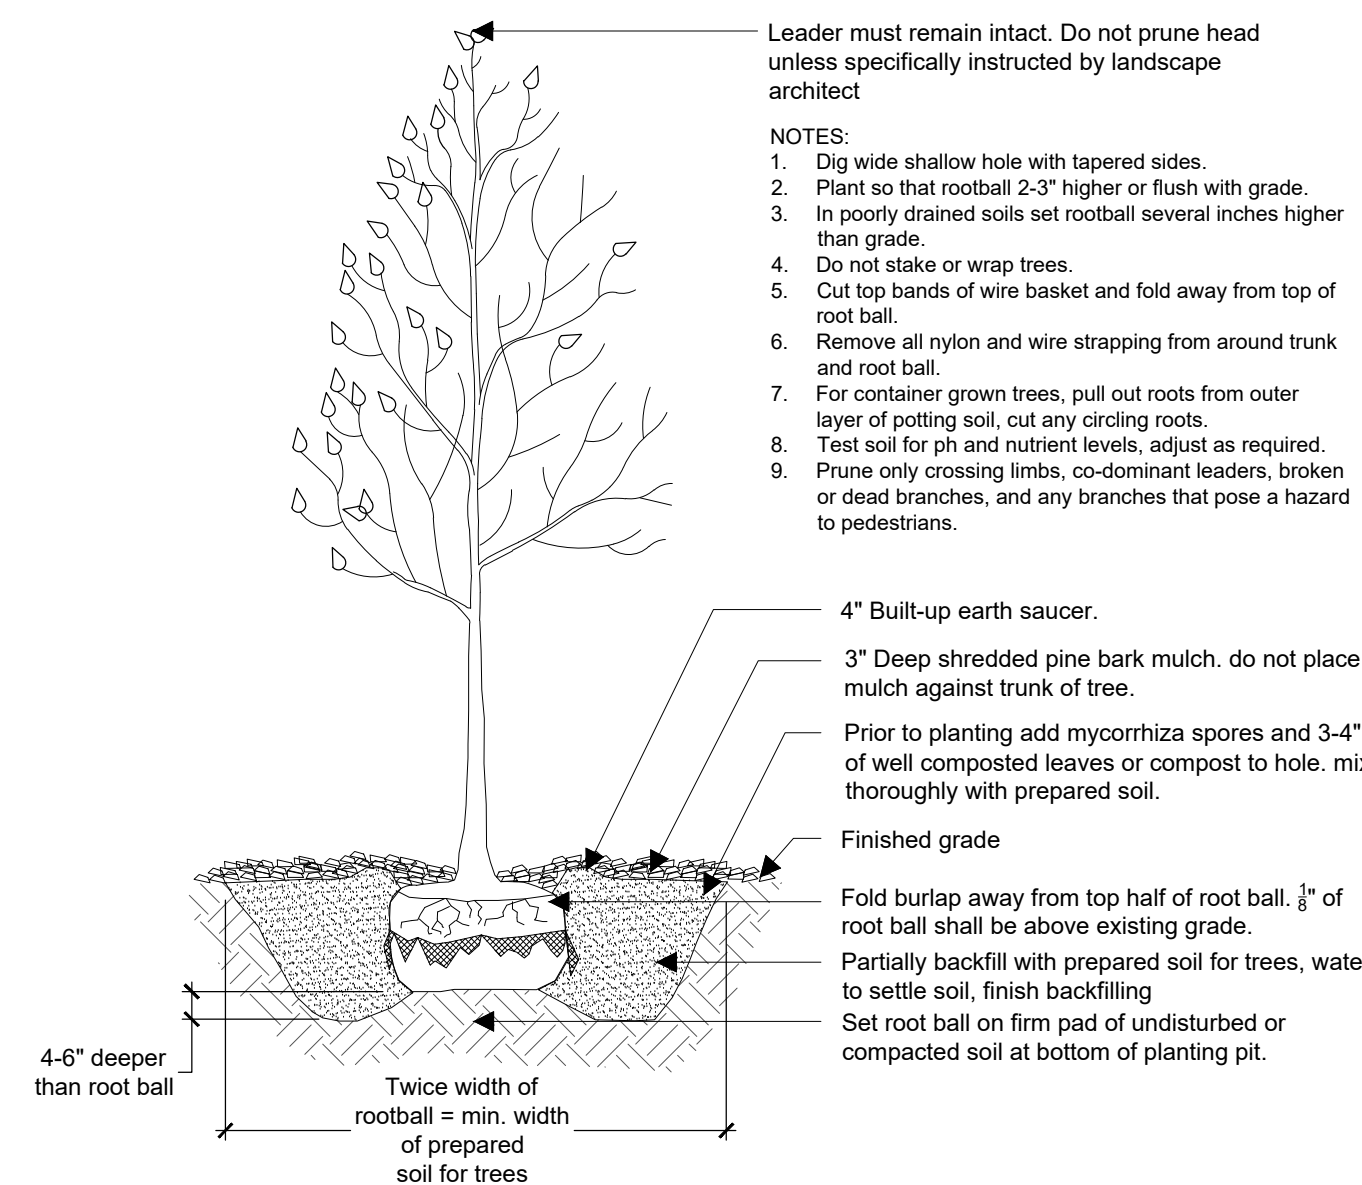

18 Deciduous Tree Planting
L-3.1


Not to Scale

NOTES

- Overall Landscape Layout and Lighting Plan - See Sheets L-1.0
- Site and Landscape Details - See Sheet L-3.0 & 3.1

1	Zoning Board Submission	12/11/2020

No. Revision: Date:

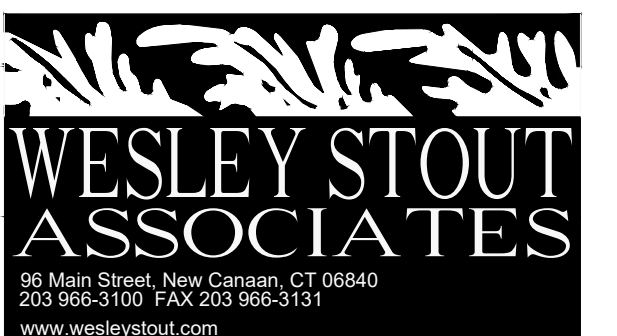

Site + Landscape Details

Date: 12/11/2020
Scale: As Noted
Sheet:

L-3.1