


2 MID-LEVEL/MEZZANINE PLAN
A1.1 SCALE: 1/8" = 1'-0"

SEE A1.3 FOR FLOORPLAN GENERAL NOTES AND KEYNOTES

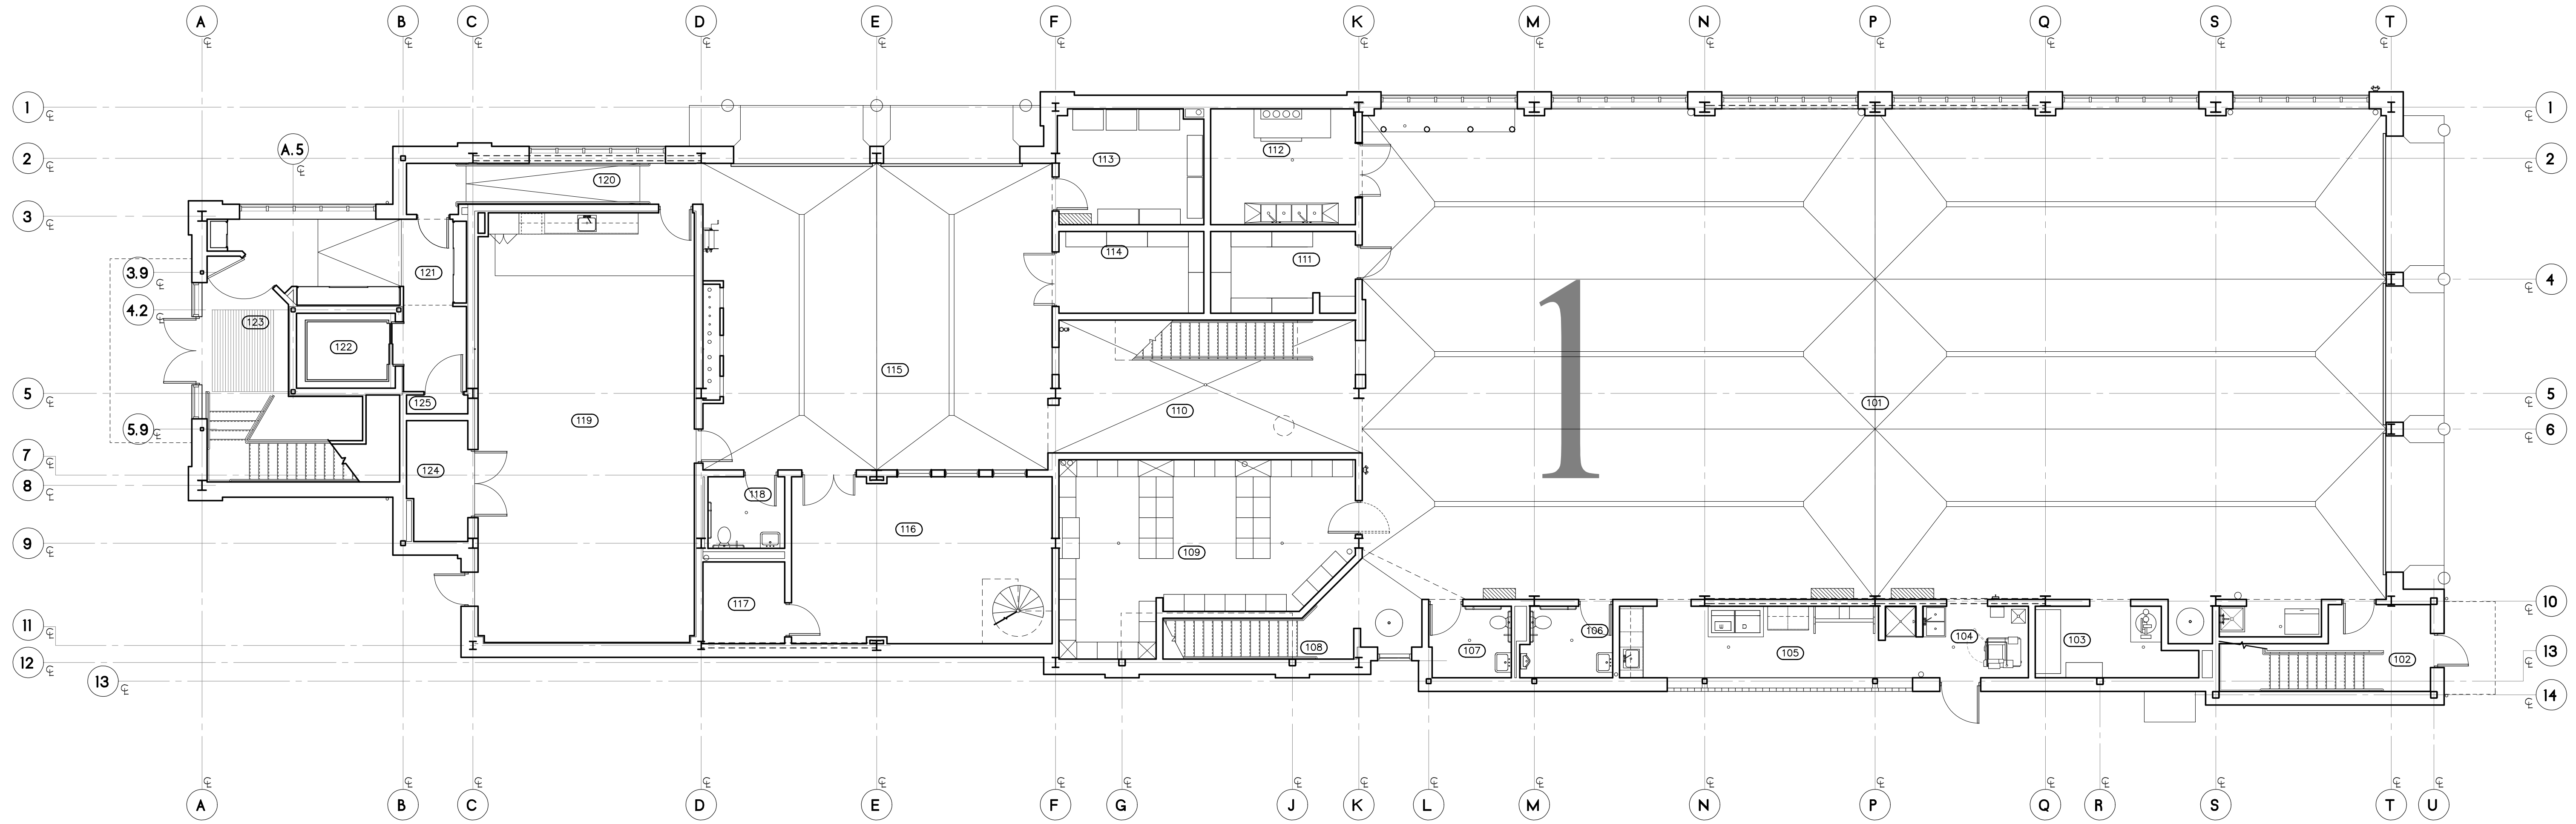

1 FIRST FLOOR PLAN
A1.1 SCALE: 1/8" = 1'-0"

FIRST FLOOR ROOM LEGEND					
NO.	NAME	NO.	NAME	NO.	NAME
101	APPARATUS BAY	104	WOMEN'S ROOM	111	STORAGE #1
102	STAIR	107	MEN'S ROOM	112	SCBA
103	WORK ROOM	108	STAIR	113	STORAGE #2 (E.O.C.)
104	DECON	109	TURNOUT GEAR	114	STORAGE #3
105	LAUNDRY	110	TRAINING AREA	115	BAY/MEDIA BRIEFING ROOM
				116	
				117	
				118	
				119	
				120	
				121	
				122	
				123	
				124	
				125	

MID-LEVEL/MEZZANINE ROOM LEGEND			
NO.	NAME	NO.	NAME
MO1	STAIR	MO4	DATA CENTER
MO2	MEZZANINE	MO7	DATA CENTER WORK ROOM /PH200
MO3	MEZZANINE TRAINING AREA	MO8	ELEVATOR LOBBY
MO4	STAIR	MO9	ELEVATOR
MO5	EXERCISE	MO10	ELEVATOR CONTROL ROOM

PACHECO ROSS ARCHITECTS, P.C.

**NEW FIRE STATION
NORWALK FIRE HEADQUARTERS**

121 CONNECTICUT AVENUE NORWALK, CT 06854-1523
72 Voorheesville Avenue P.O. Box 558 Voorheesville, NY 12166 (518) 765-5105 fax: 765-5107

COPYRIGHT 2010
PACHECO ROSS ARCHITECTS, P.C.
Unauthorized alteration or addition to
this document is a violation of law.

FIRST FLOOR & MID-LEVEL/MEZZANINE PLANS
SCALE: AS NOTED
DWG. BY: DAR/DJP/KSP/JDA
DWG. ID#: DWG ID# NW_A1X.DC5

REV	DATE	DESCRIPTION

STATUS: CD ESTIMATE

A1.1